


First Floor Plan

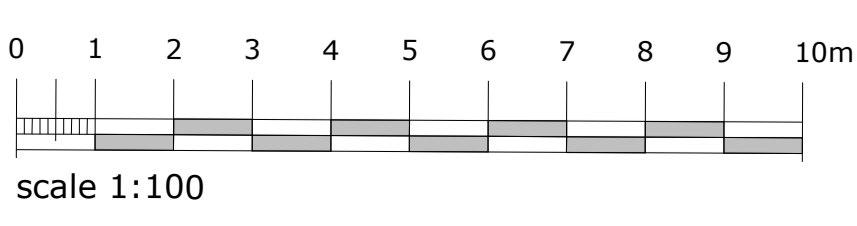

campbell driver partnership
 architects designers surveyors

client: the Globe
 project: the vue
 the viaduct, hyndburn road accrington
 sheet: Proposed retail unit

dwg no: 13.195	13
scale: 1:100	capricorn park blakewater road blackburn bb1 5qr t: 01254 297700 f: 01254 297701 email: design@cdparchitects.co.uk
date: 12-10-2015	
drawn: H.S	